


**GENERAL NOTES:**

1. THIS DRAWING IS TO BE READ IN CONJUNCTION WITH ALL RELEVANT ARCHITECTS AND ENGINEERS DRAWINGS AND SPECIFICATIONS.
2. DO NOT SCALE THIS DRAWING. ANY AMBIGUITIES, OMISSIONS AND ERRORS ON DRAWINGS SHALL BE BROUGHT TO THE ENGINEERS ATTENTION IMMEDIATELY. ALL DIMENSIONS MUST BE CHECKED / VERIFIED ON SITE.
3. ALL DIMENSIONS ARE IN METRES UNLESS NOTED OTHERWISE.
4. FOR GENERAL NOTES REFER TO DRAWING.

- KEY**
- SURFACE WATER DRAIN
  - FILTER DRAIN
  - ▨ GRANULAR SUBBASE ATTENUATION
  - ▨ PERMEABLE PAVING WITH SUBBASE ATTENUATION
  - ▨ PERMEABLE MUGA CONSTRUCTION WITH SUBBASE ATTENUATION
  - ▨ GRALE

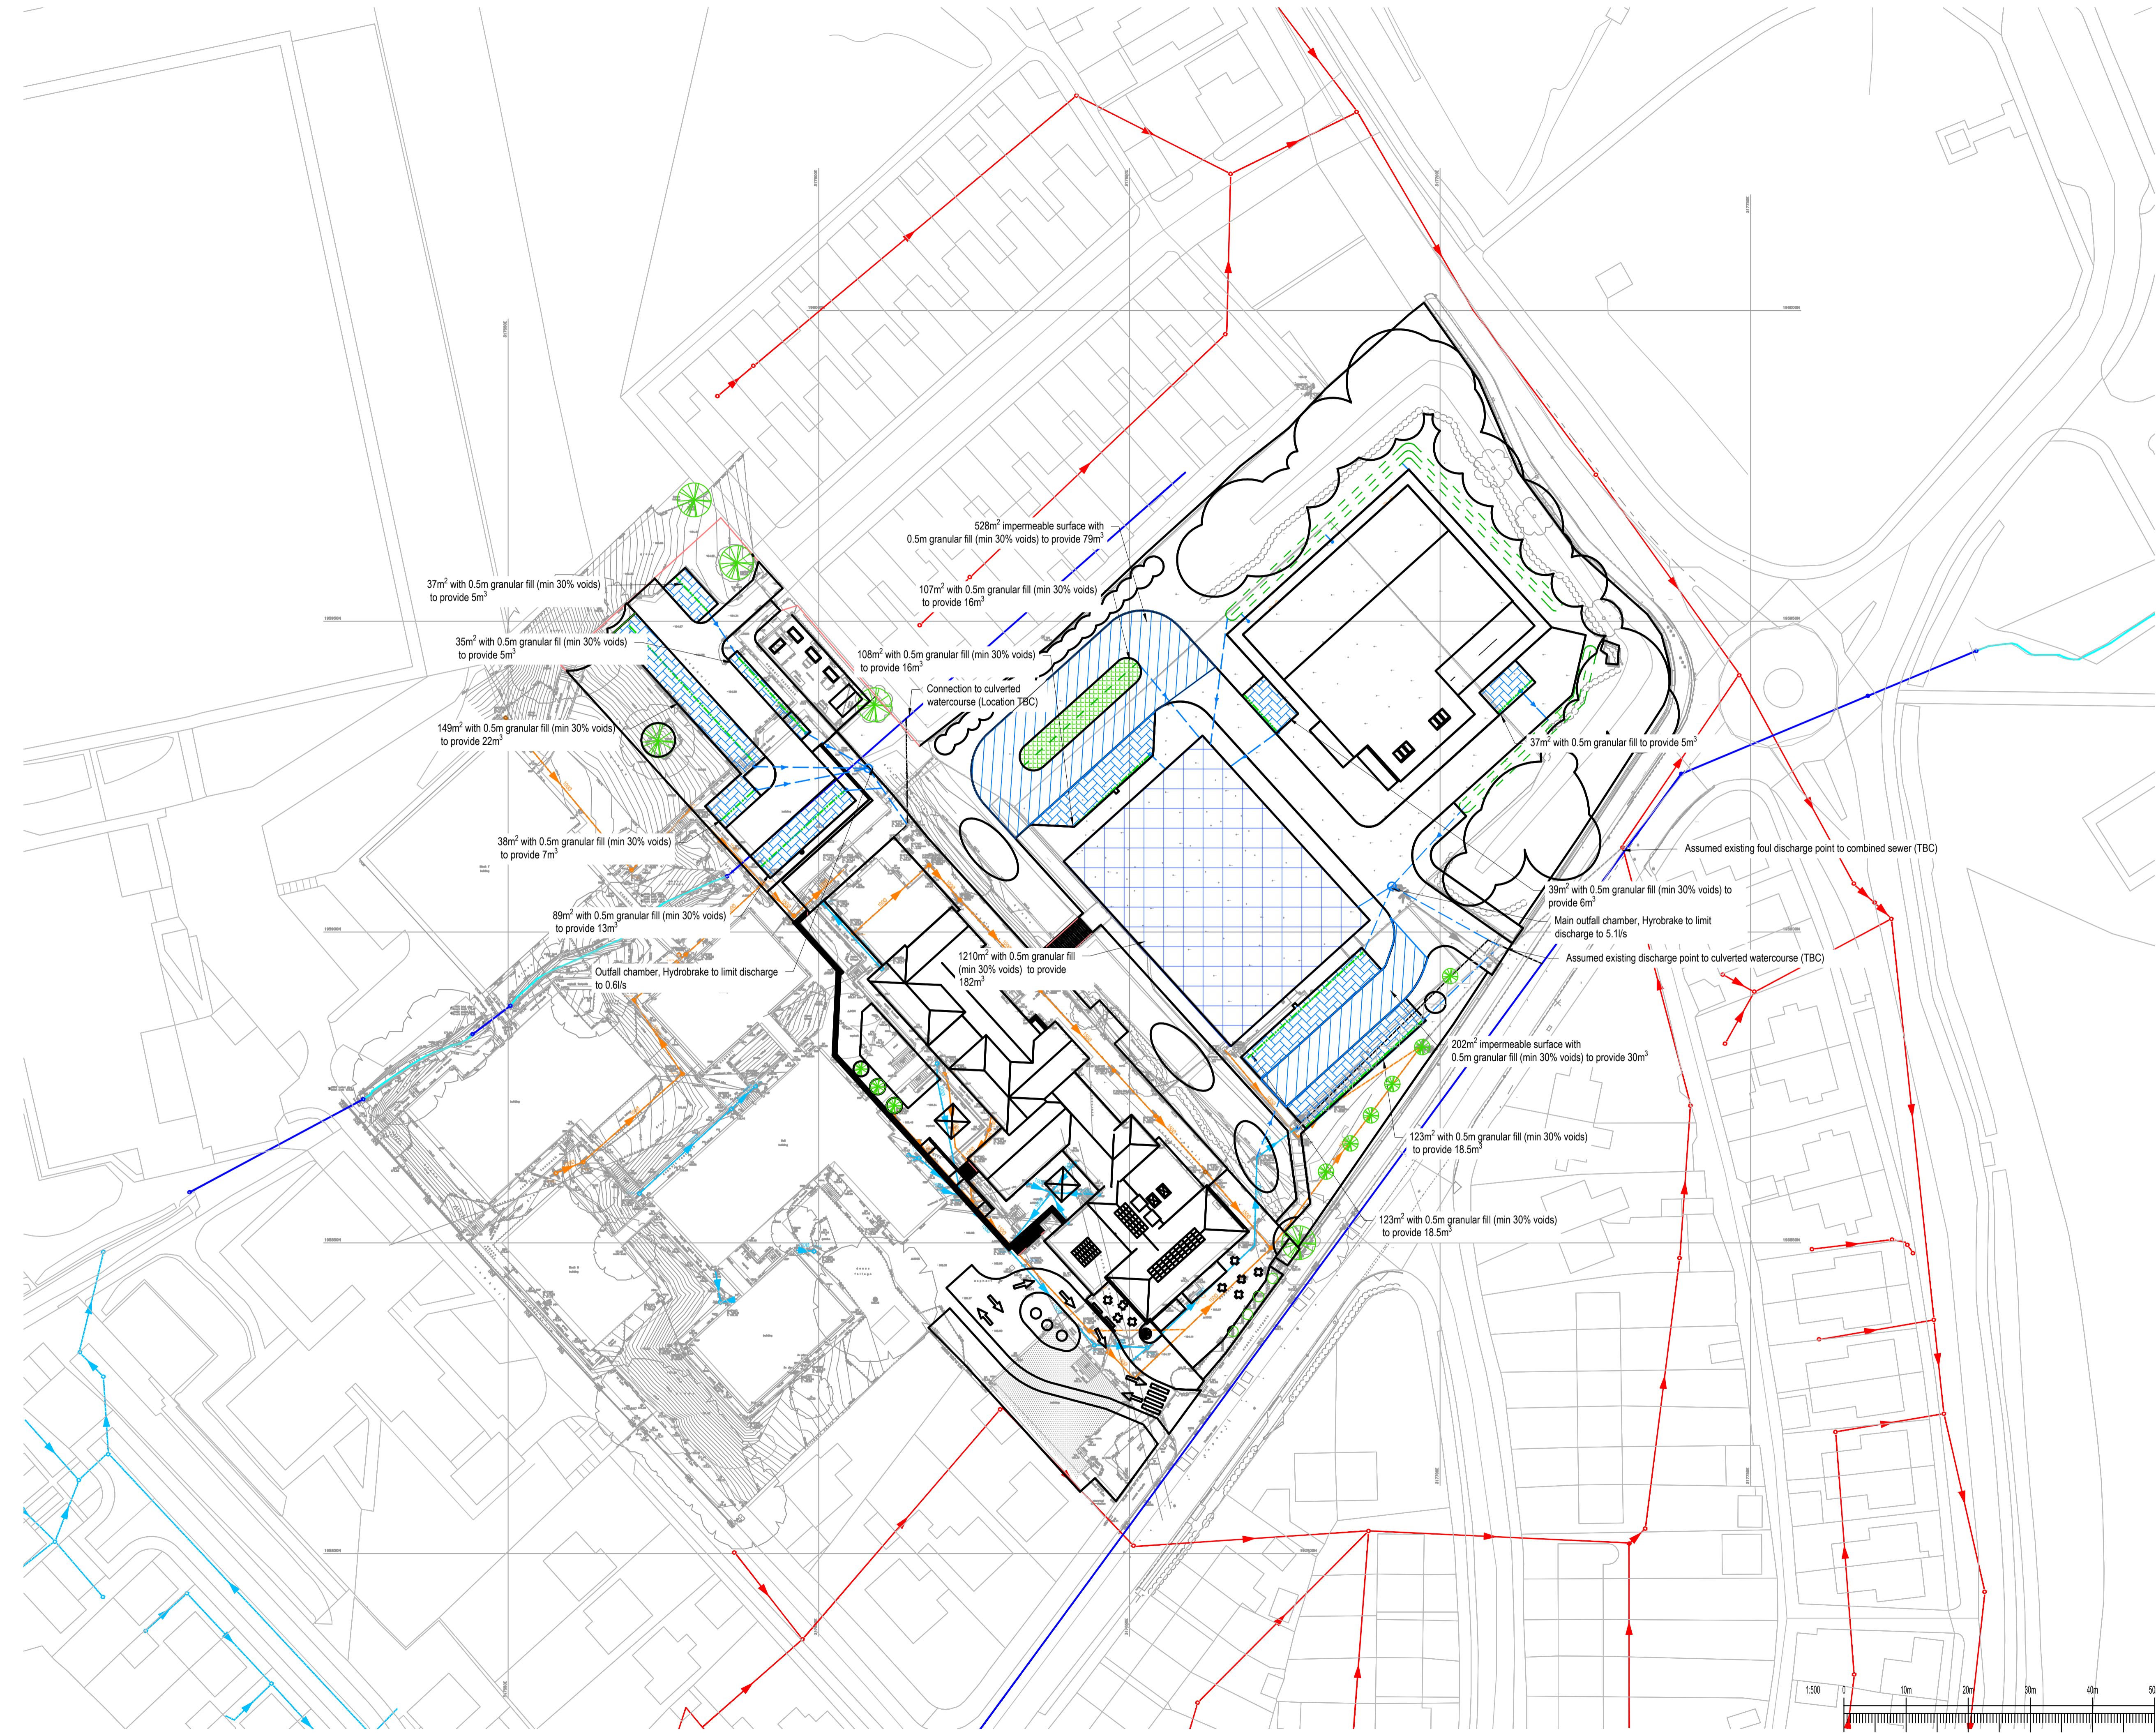

P04	UPDATED TO SUIT NEW OUTFALL LOCATIONS	05/08/22	JT	SCD
P03	DRAINAGE UPDATED	20/07/22	JT	SCD
P02	AMENDED TO SUIT NEW LAYOUT	28/04/22	JT	SCD
P01	FIRST ISSUE	13/04/22	JT	SCD
Rev:	Description:	Date:	By:	Chkd:

**curtins**

Unit 3, Cwrt-y-Parc, Earlswood Road, Cardiff, CF14 5GH  
 029 2068 0000  
 cardiff@curtins.com  
 www.curtins.com

Civils & Structures - Transport Planning - Environmental - Infrastructure - Geotechnical - Conservation & Heritage - Principal Designer  
 Birmingham - Bristol - Cambridge - Cardiff - Douglas - Dublin - Edinburgh - Glasgow - Kendal - Leeds - Liverpool - London - Manchester - Nottingham

Status: **SUITABLE FOR INFORMATION** **S2**

Project: **PONTLLANFRAITH COMPREHENSIVE**

Dig Title: **PROPOSED DRAINAGE LAYOUT**

Drawn By	Designed By	Checked By
JT	JT	SCD
Project No	Date	Scales @ A1
080357	13/04/22	1:500
Project Code - Originator - Function - Spatial - Form - Discipline - Number	Revision	

080357 - CUR - XX - XX - DR - C - 92003 P04

I:\Projects\080357-Pontllanfraith-CV\LOI-Production\A-Model-Drawings\CA0921